

BUILDING CONTRACTOR/HOME OWNER
TO REVIEW AND VERIFY ALL DIMENSIONS,
SPECS, AND CONNECTIONS BEFORE
CONSTRUCTION BEGINS.

ELECTRICAL SYSTEM CODE: SEC.2701
MECHANICAL SYSTEM CODE: SEC.2801
PLUMBING SYSTEM CODE: SEC.2901

EX.LOWER LEVEL BASEMENT PLAN
SCALE 1/4" = 1'-0"

ABSOLUTE GREEN HOMES CORPORATION
33 TRUESDALE DRIVE
SOUTH SALEM, NY 10590
PHONE 914-977-3088
FAX 914-977-5094
WEB absoluteremodeling.com
WESTCHESTER LIC. #WC-6322-H94
CONNECTICUT LIC. #00561535



DRAWING INDEX:
A-1 PROPOSED FLOOR PLAN
A-2 SECTION DETAILS
E-1 ELECTRICAL PLAN
X-1 EXISTING FLOOR PLAN


REVISIONS:	DATE
FLOOR PLAN	7-20-06

DRAWING DESCRIPTION:
EXISTING LOWER LEVEL FLOOR PLAN

PROJECT DESCRIPTION:
LOWER LEVEL REMODELING FEATURES FITNESS CENTER-
HOME THEATRE-GAME AREA-PLAYSPACE WITH TOY
STORAGE-WINE CELLER-STORAGE CLOSETS-FULL
BATH-OPEN STAIRWAY-BUILT IN CABINETRY

DATE: 6-20-06
SCALE: 1/4"=1'-0"
DRAWN BY: R.T.ECKENRODE

DRAWING #
X-1

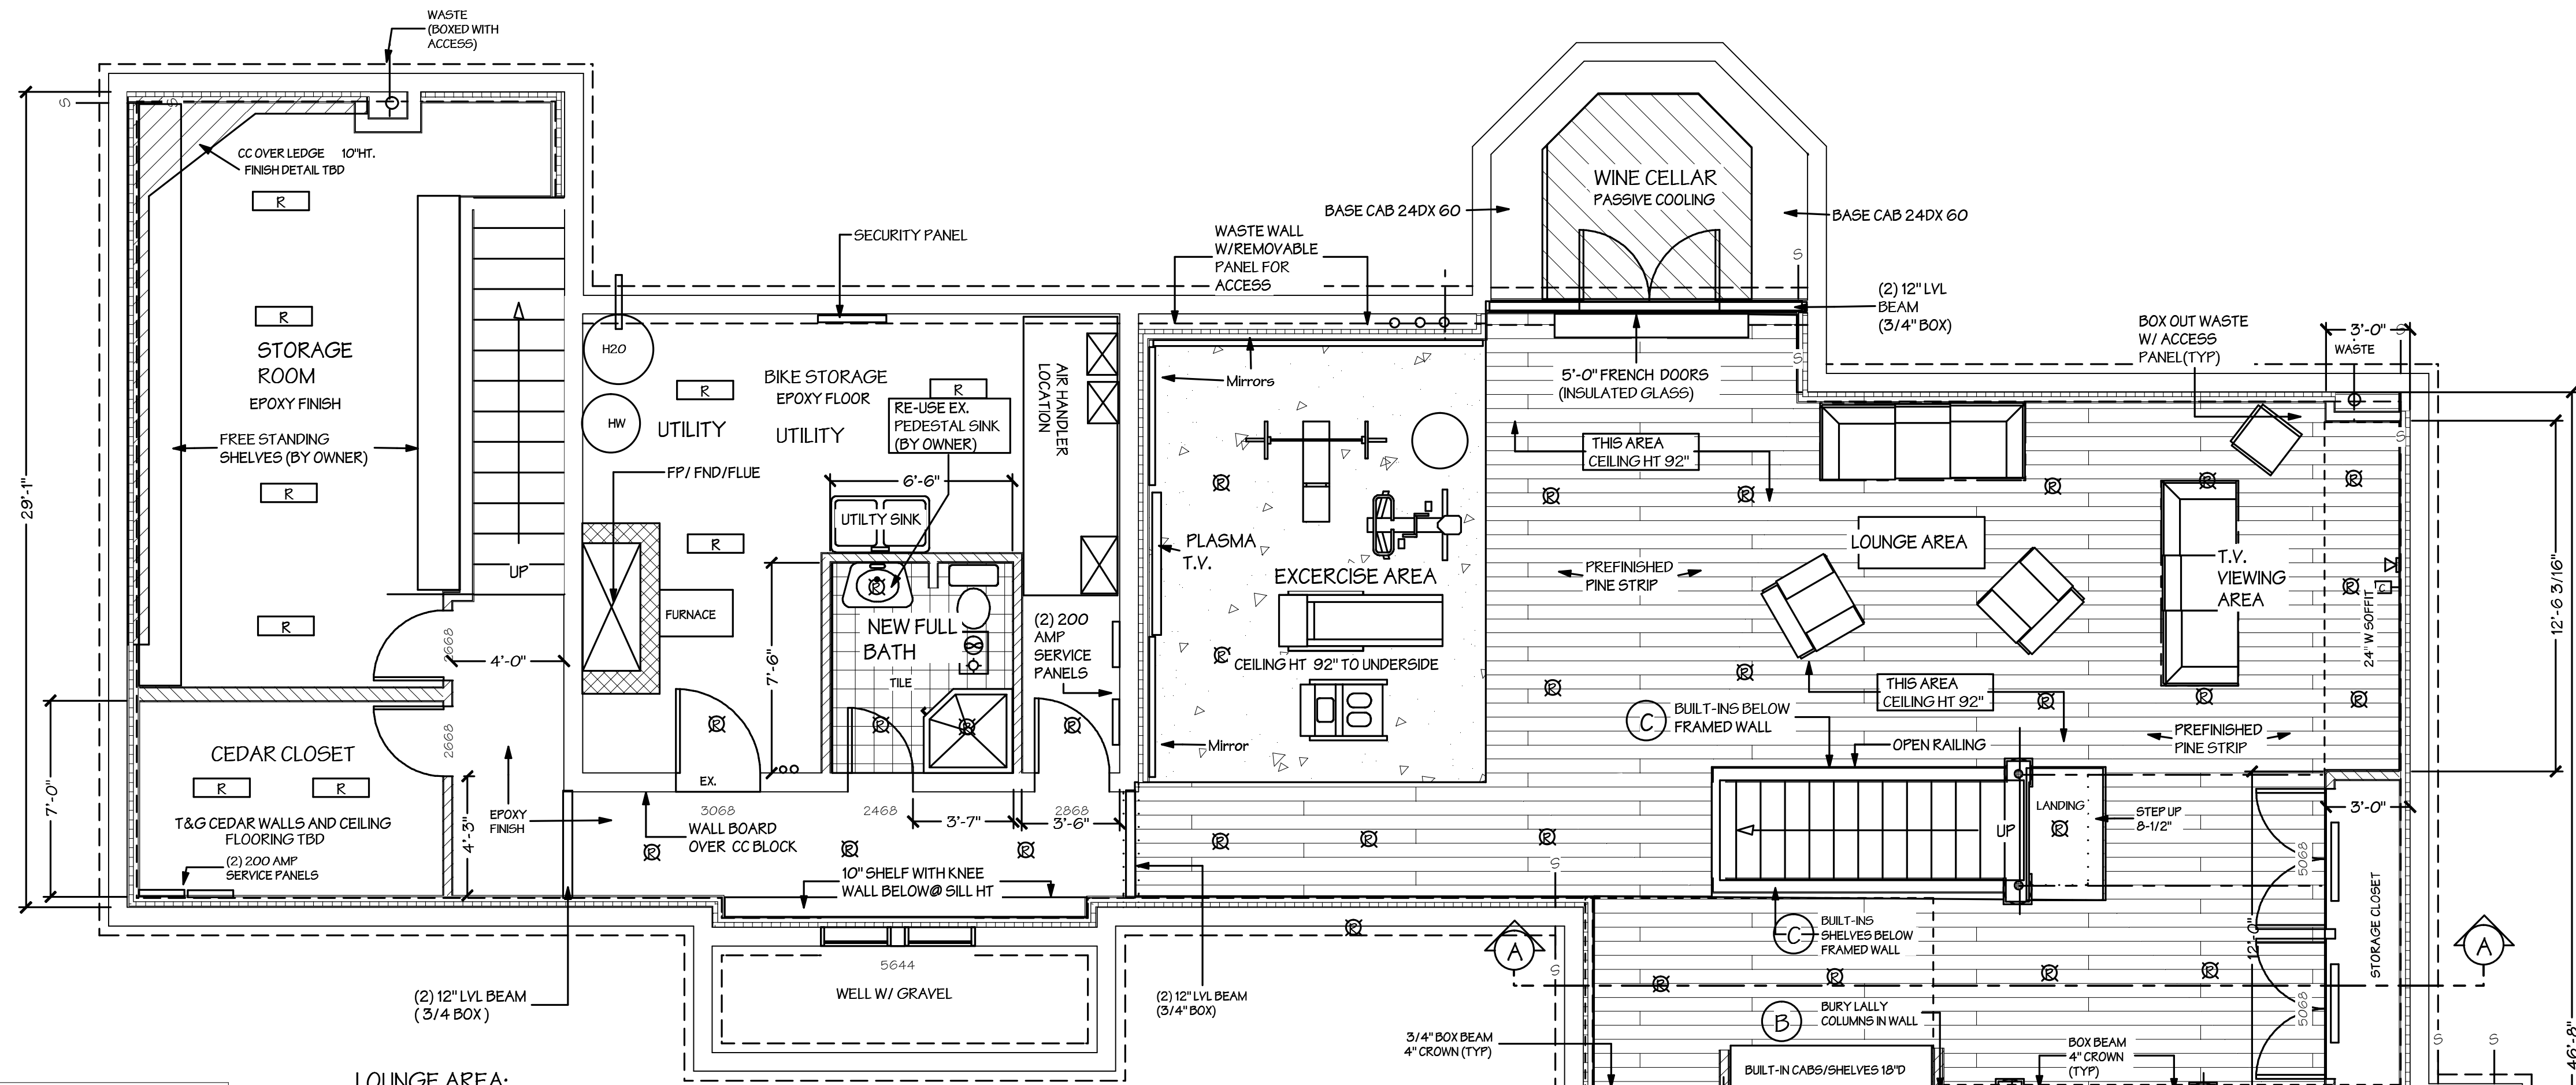

WINE CELLAR:
 FEATURES CLIMATE CONTROLLED AREA FOR WINE STORAGE, BASE CAB AND TERRA COTTA TILE FLOORING

EXERCISE AREA:
 FEATURES CORK OR RUBBER FLOORING WITH MIRROR WALLS AND PLASMA T.V.

FULL BATH:
 FEATURES 40" X 40" SHOWER, VANITY AND WATER CLOSET

UTILITY ROOM:
 HOME TO ALL MECHANICALS, SECURITY SYSTEM, WASH UP SINK AND BIKE AND PARTS STORAGE

MAIN CLOSET:
 FEATURES LARGE SPACE WITH SHELVING TO ORGANIZE STORAGE

CEDAR CLOSET:
 FEATURES FULLY LINED CEDAR SPACE FOR CLOTHES STORAGE

LOUNGE AREA:
 FEATURES COMFORTABLE SEATING AREA WITH CARPETING FOR RELAXATION

T.V. VIEWING AREA:

CENTRAL CLOSET:
 FEATURES WALK IN STORAGE WITH SHELVES


PLAY SPACE:
 FEATURES CRAFT AREA SEATING, TV, AND STORAGE FR TOYS

GAME AREA:
 FEATURES SUNLIGHT SPACE WITH ROOM FOR TABLE GAMES, SEATING AREA AND STORAGE SPACE FOR STEREO COMPONENTS

CENTER STORAGE ISLAND:
 FEATURES MATCHING BUILT-IN STORAGE UNITS CENTRALLY LOCATED

3/4 OVERVIEW OF LOWER LEVEL REMODEL

LOWER LEVEL BASEMENT PLAN
 SCALE 1/4" = 1'-0"

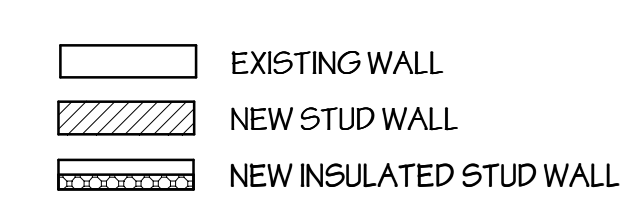

NOTE: SMOKE DETECTORS EACH ROOM AND HALLWAYS

ABSOLUTE GREEN HOMES CORPORATION
 33 TRUESDALE DRIVE
 SOUTH SALEM, NY 10590
 PHONE 914-977-3088
 FAX 914-977-5094
 WEB absolute remodeling.com
 WESTCHESTER LIC. #WC-C322-H94
 CONNECTICUT LIC. #00561535




DRAWING INDEX:
 A-1 PROPOSED FLOOR PLAN
 A-2 SECTION DETAILS
 E-1 ELECTRICAL PLAN
 X-1 EXISTING FLOOR PLAN

 
REVISIONS:	DATE
FLOOR PLANS	7-22-06
FLOOR PLANS	7-29-06
FLOOR PLANS	8-12-06
FLOOR PLANS	8-16-06


 
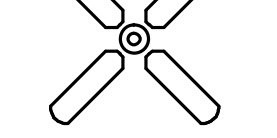

 

 
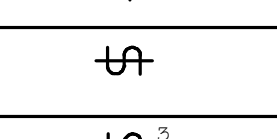
 
 
 

 

 
 
 
 
 
 





DRAWING DESCRIPTION:
PROPOSED LOWER LEVEL FLOOR PLAN
 PROJECT DESCRIPTION:
 LOWER LEVEL REMODELING FEATURES FITNESS CENTER, HOME THEATRE, GAME AREA, PLAY SPACE WITH TOY STORAGE, WINE CELLAR, STORAGE CLOSETS, FULL BATH, OPEN STAIRWAY, BUILT IN CABINETS

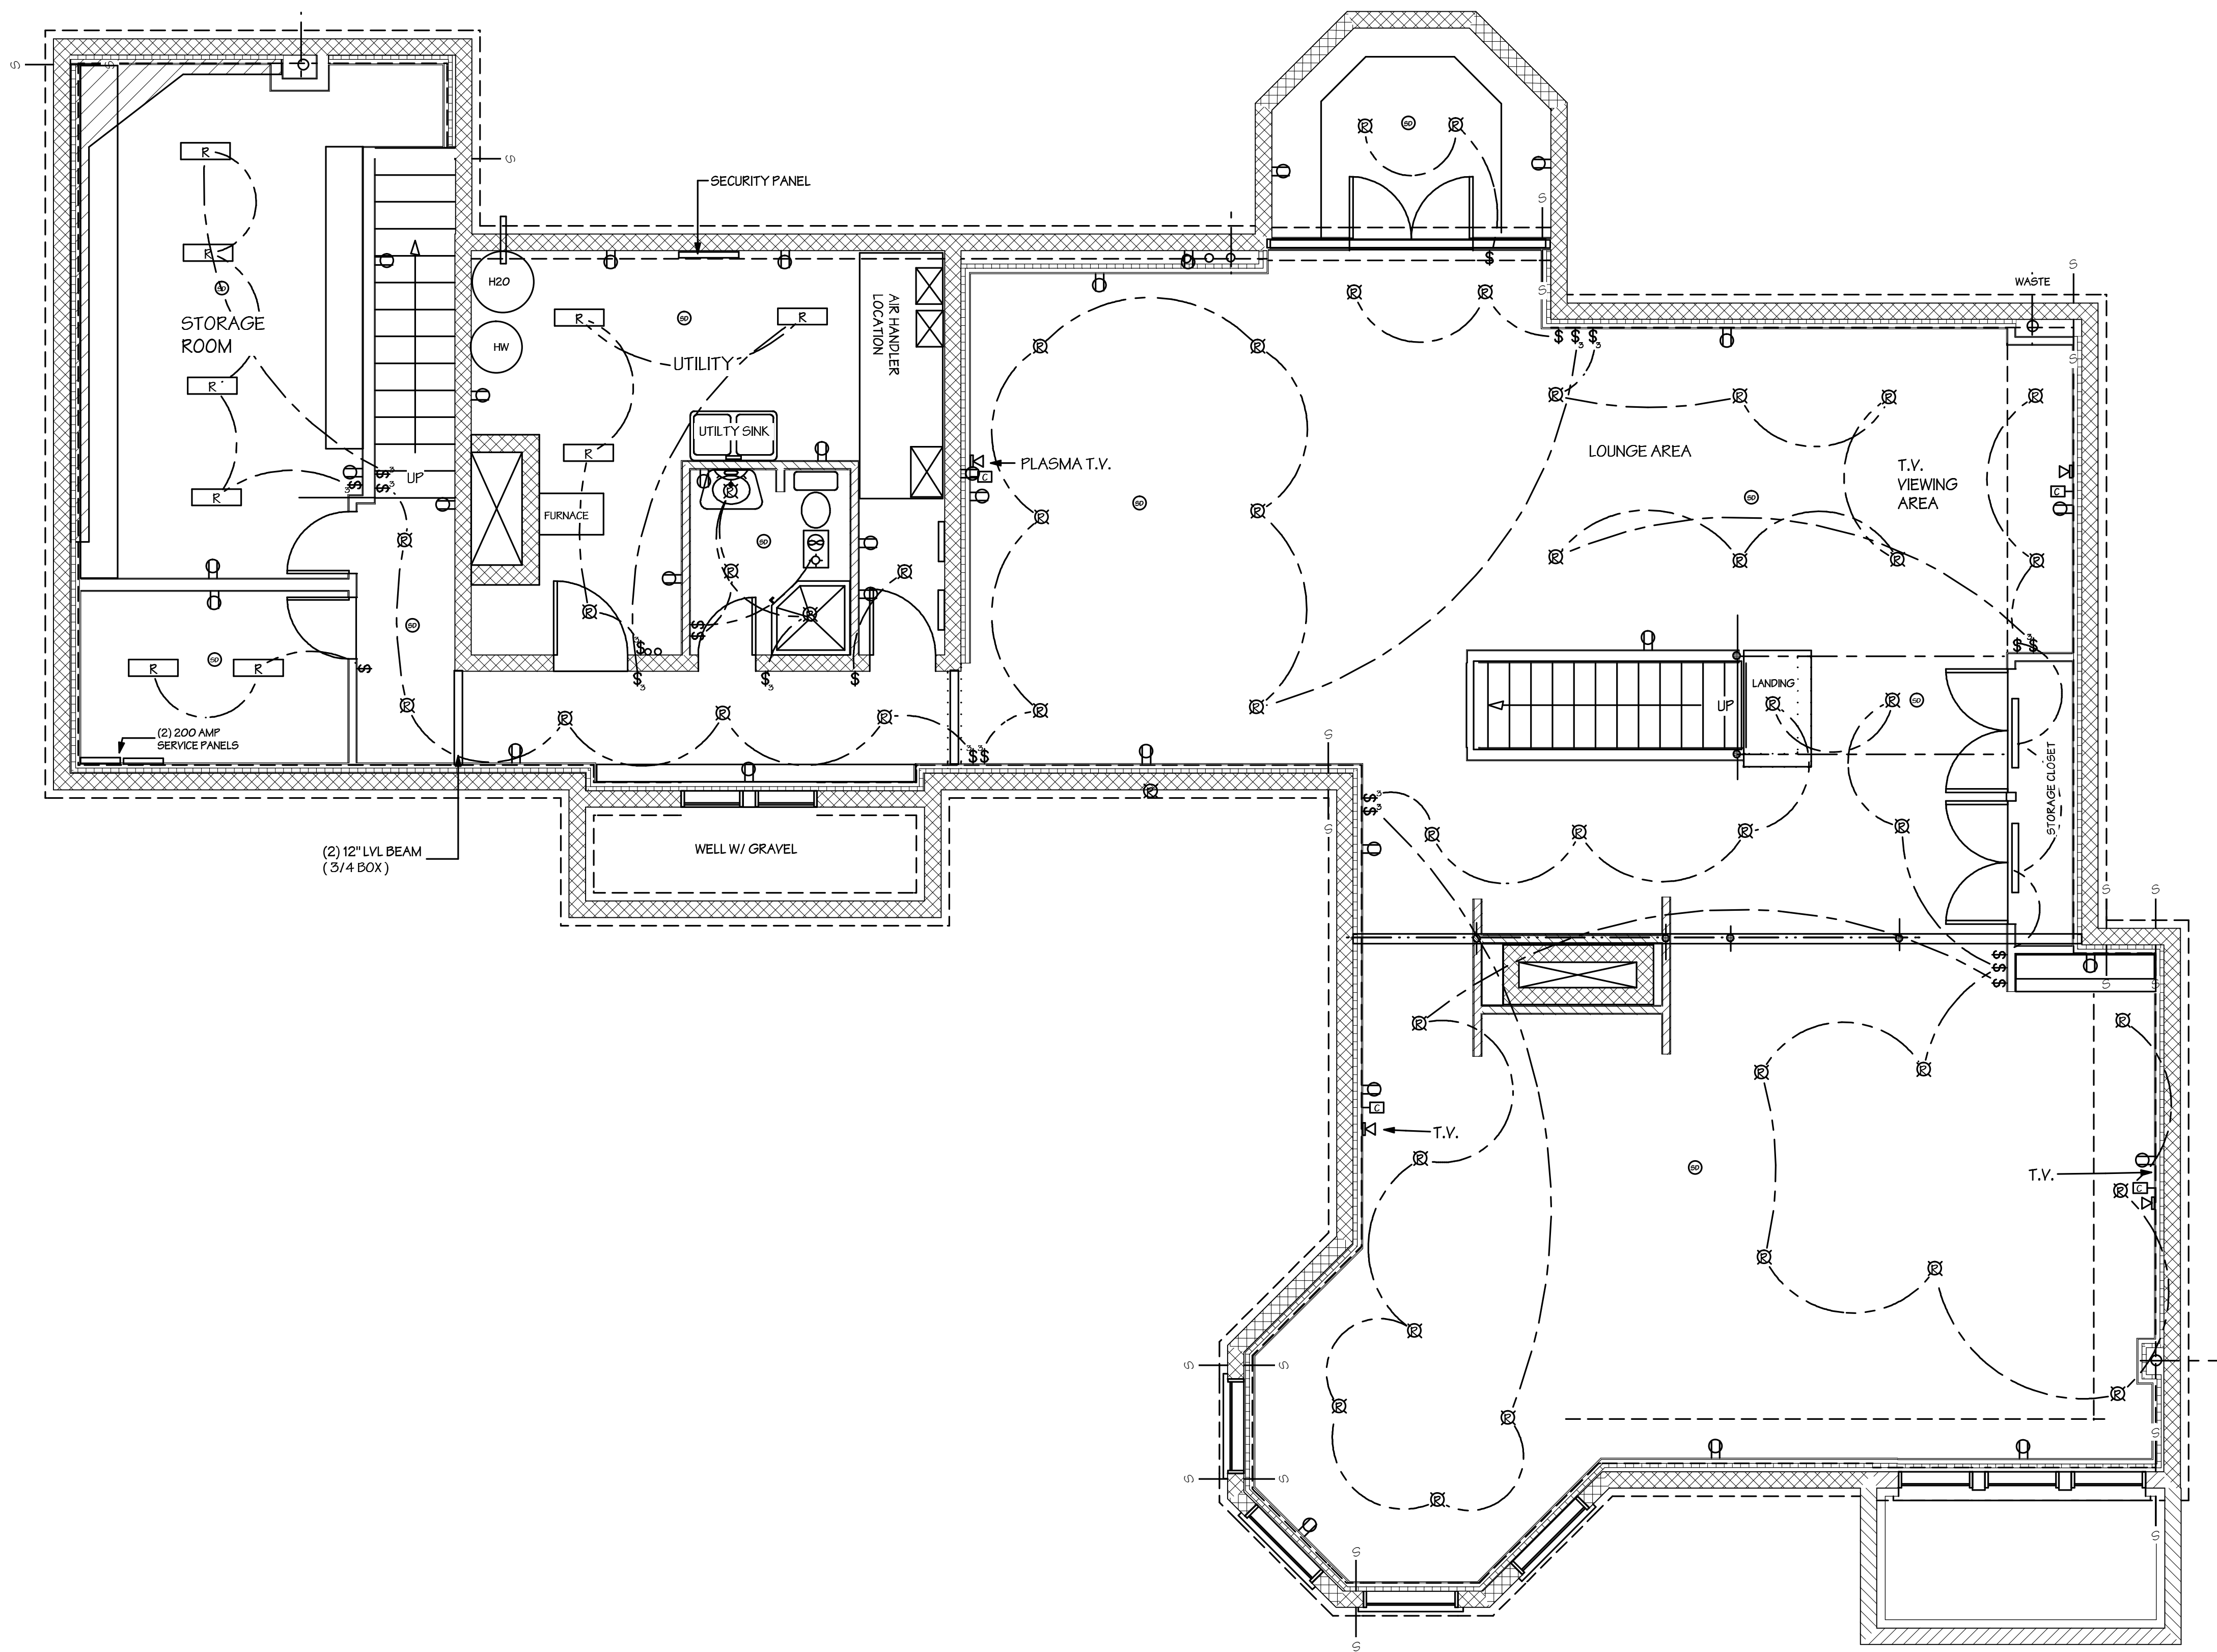DATE: 6-26-06
 SCALE: 1/4"=1'-0"
 DRAWN BY: R.T.ECKENRODE

DRAWING #
A-1




LOWER LEVEL ELECTRICAL PLAN
 SCALE 1/4" = 1'-0"

ELECTRICAL LEGEND	
SYMBOL	DESCRIPTION
	METER SOCKET
	PANEL BOX
	CEILING FAN W/ LIGHT
	FLUORESCENT LIGHT FIXTURE
	110V CEILING LIGHT FIXTURE
	110V RECESSED LIGHT FIXTURE
	110V EAVE LIGHT FIXTURE
	110V CHANDLIER LIGHT FIXTURE
	110V WALL LIGHT FIXTURE
	SINGLE POLE SWITCH
	THREE WAY SWITCH
	FOUR WAY SWITCH
	DIMMER SWITCH
	OUTDOOR SWITCH
	110V DUPLEX RECEPTACLE
	110V DUPLEX RECEPTACLE GROUND FAULT INTERRUPTED
	110V DUPLEX RECEPTACLE W/ WEATHERPROOF COVER
	110V FLOOR MOUNTED DUPLEX RECEPTACLE
	240V RECEPTACLE
	TELEPHONE JACKS
	TELEVISION JACKS
	DOOR BELL PUSH BUTTON
	THERMOSTAT
	SMOKE DETECTOR
	EXHAUST FAN
	DOOR CHIME
	FIRE ALARM PANEL
	COMPUTER POINT

ABSOLUTE GREEN HOMES CORPORATION
 33 TRUESDALE DRIVE
 SOUTH SALEM, NY 10590
 PHONE 914-977-3088
 FAX 914-977-5094
 WEB absoluteremodelling.com
 WESTCHESTER LIC. #WC-C322-H94
 CONNECTICUT LIC. #00561535



DRAWING INDEX:
 A-1 PROPOSED FLOOR PLAN
 A-2 SECTION DETAILS
 E-1 ELECTRICAL PLAN
 X-1 EXISTING FLOOR PLAN

REVISIONS:	DATE
ELECTRICAL PLAN	8-16-06

DRAWING DESCRIPTION:
PROPOSED LOWER LEVEL ELECTRICAL PLAN
PROJECT DESCRIPTION:
 LOWER LEVEL REMODELING FEATURES FITNESS CENTER-
 HOME THEATRE-GAME AREA-PLAYSPACE WITH TOY
 STORAGE-WINE CELLER-STORAGE CLOSETS-FULL
 BATH-OPEN STAIRWAY-BUILT IN CABINETRY

DATE: 7-20-06
 SCALE: 1/4"=1'-0"
 DRAWN BY: R.T.ECKENRODE

DRAWING #
E-1